


Ground floor plan

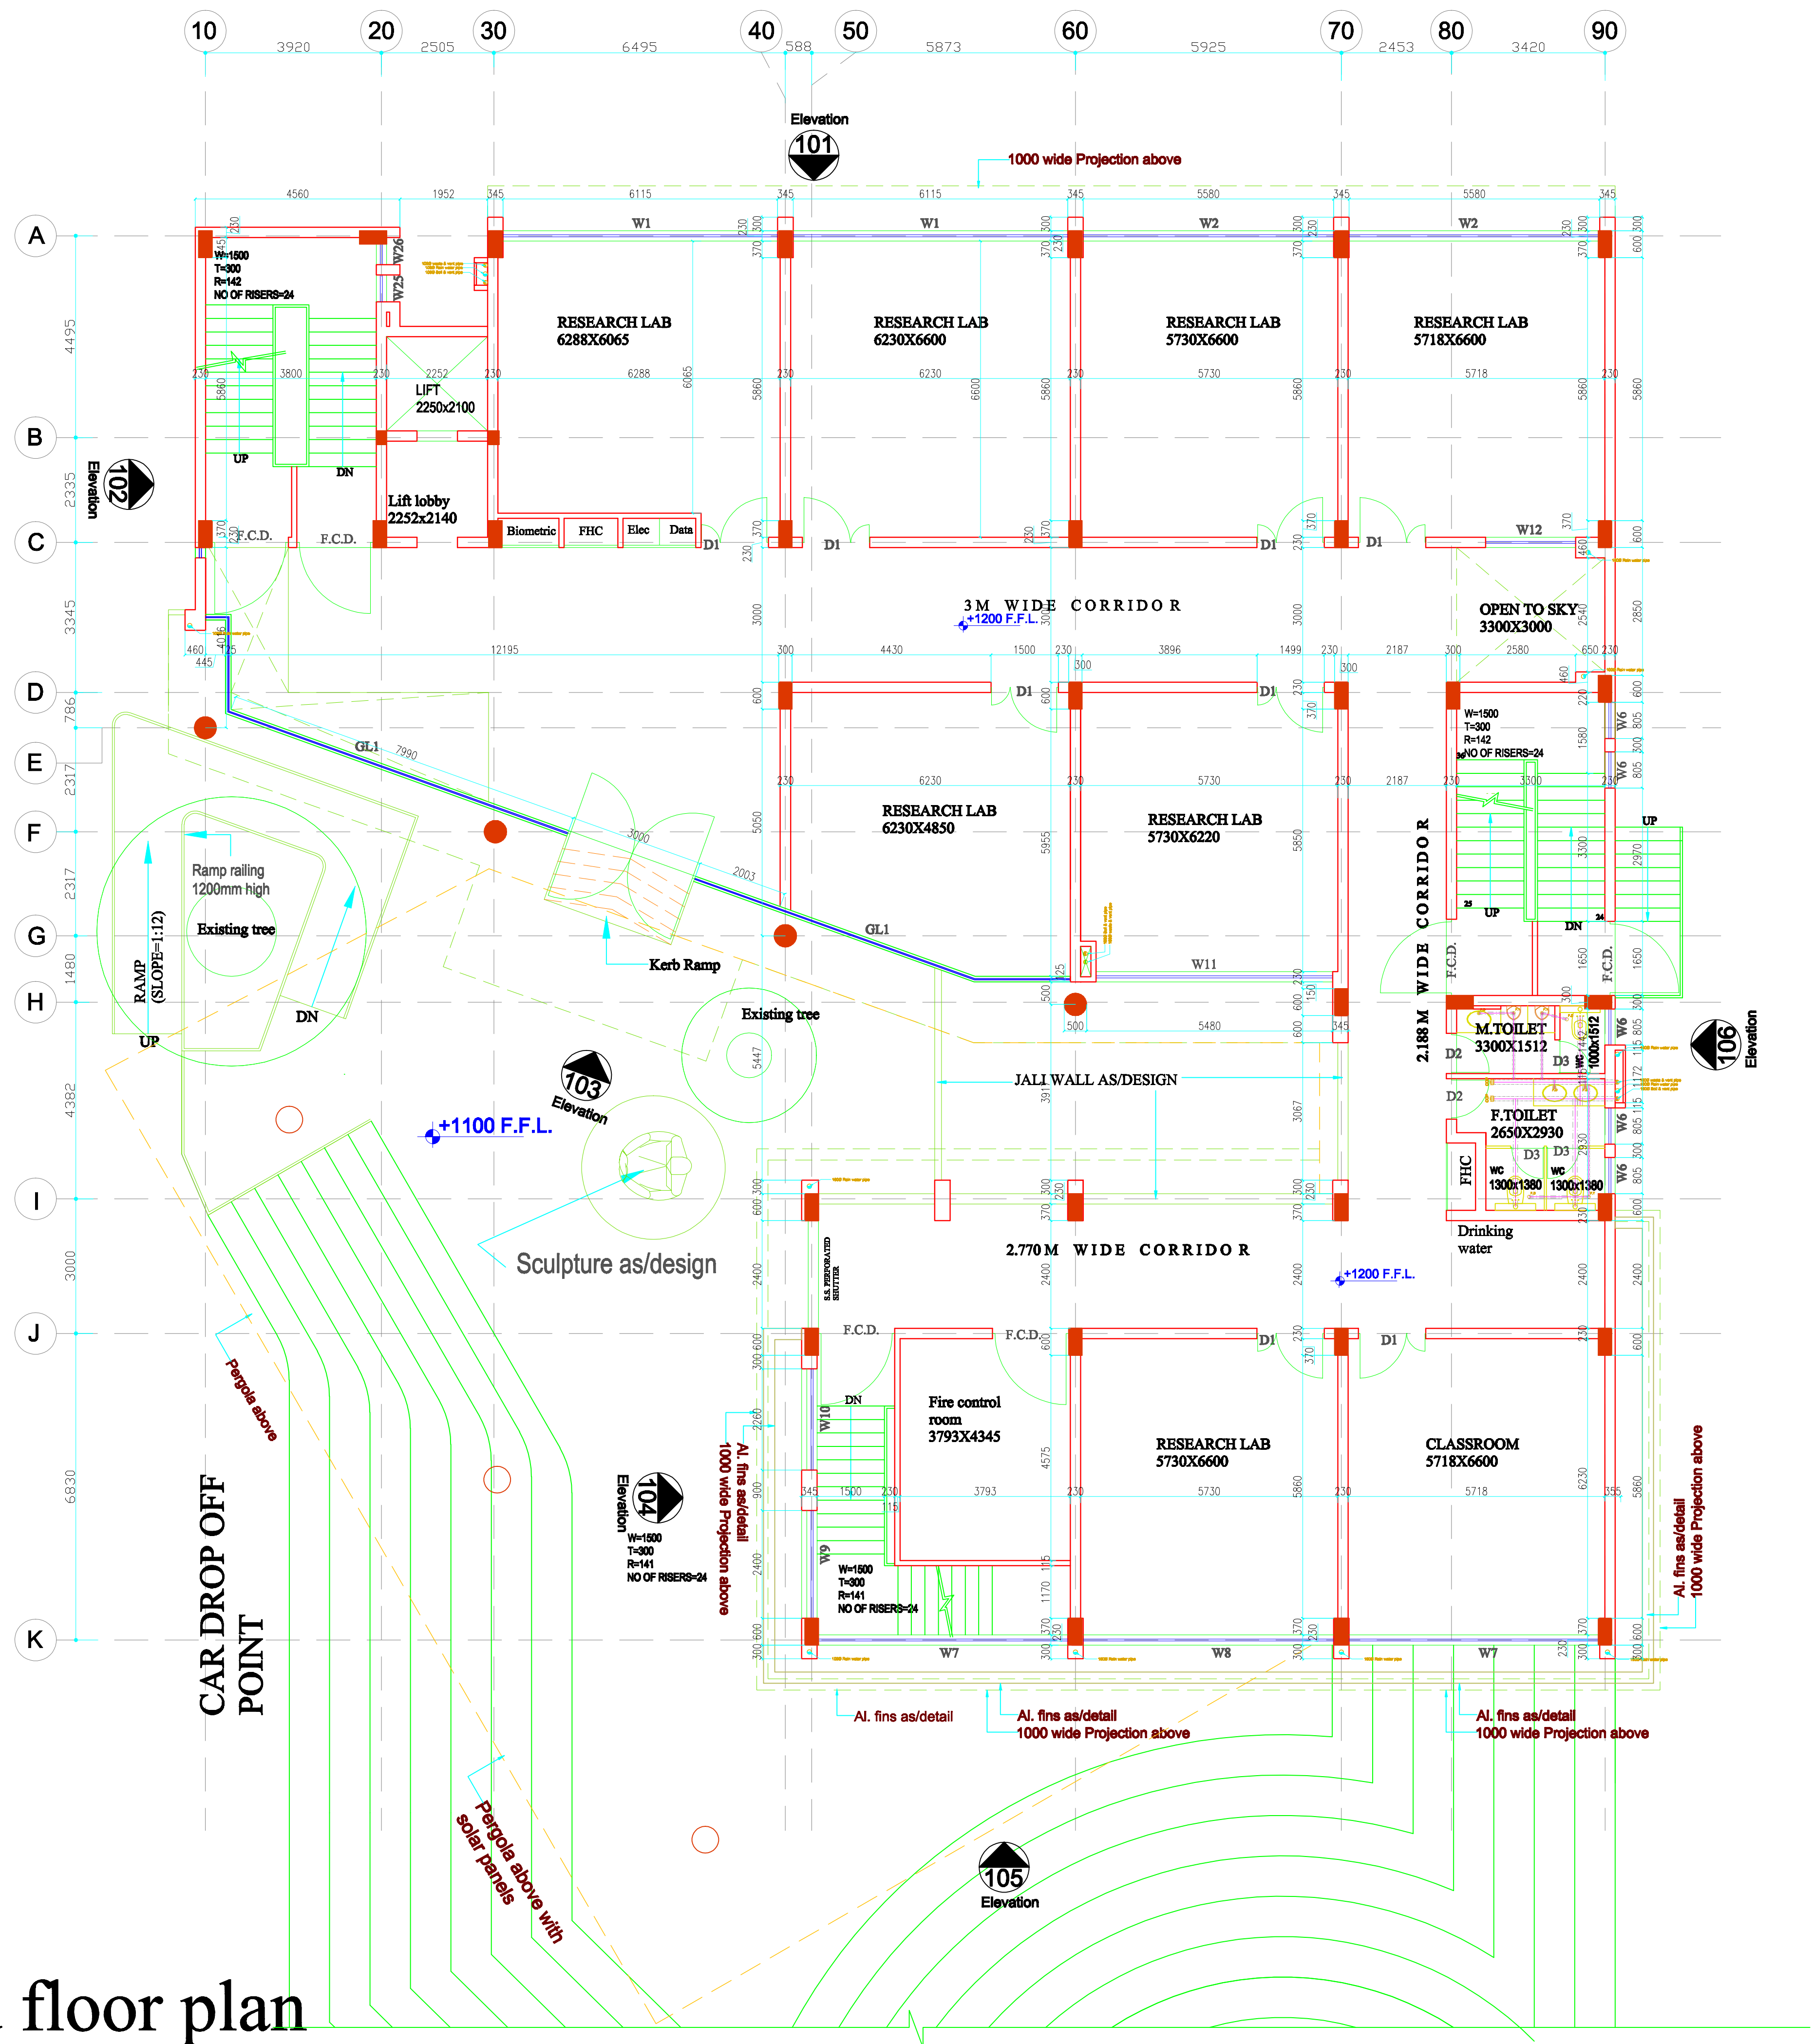

NOTES

- THIS DRAWING IS INTELLECTUAL COPYRIGHT OF "MS PRABHAT KUMAR & ASSOCIATES"
- WRITTEN DIMENSION TO BE FOLLOWED, DRAWING NOT TO BE SCALED.
- CONTRACTOR MUST VERIFY ALL DIMENSION ON SITE BEFORE COMMENCING ANY WORK.

NOTE :- 1. Cover 40 mm in exposed R.C.C. Slabs, beams and vertical walls in place of normal 25 mm

- Coordinated with
- Structure
 - Sanitary / Water Supply
 - HVAC
 - Electrical
 - Interior
 - Landscape

Architects
Prabhat Kumar & Associates
architects, planners and project management consultants
RMT-316, B-2, Mahaveera Tower, LSC,
Next to Geetanjali Hospital, Geetanjali,
Near Aurobindo College, ND-17.
Ph: 011-41882233, 9889228494, 988555511
E-mail: prabhat_arch@yahoo.com

Project
**PROPOSED RESEARCH CENTER
HINDU COLLEGE, DELHI
UNIVERSITY, DELHI**

Client
**HINDU COLLEGE, DELHI
UNIVERSITY, DELHI**

Title
**GROUND FLOOR WORKING PLAN
GROUND FLOOR SANITARY PLAN**

Date
08.03.2016

Scale

Checked by
PRABHAT

Drawn by
KARAN SHARMA

Project no.
1008

Drawing no.
**AW - 02
PL - 02**