


Third floor plan

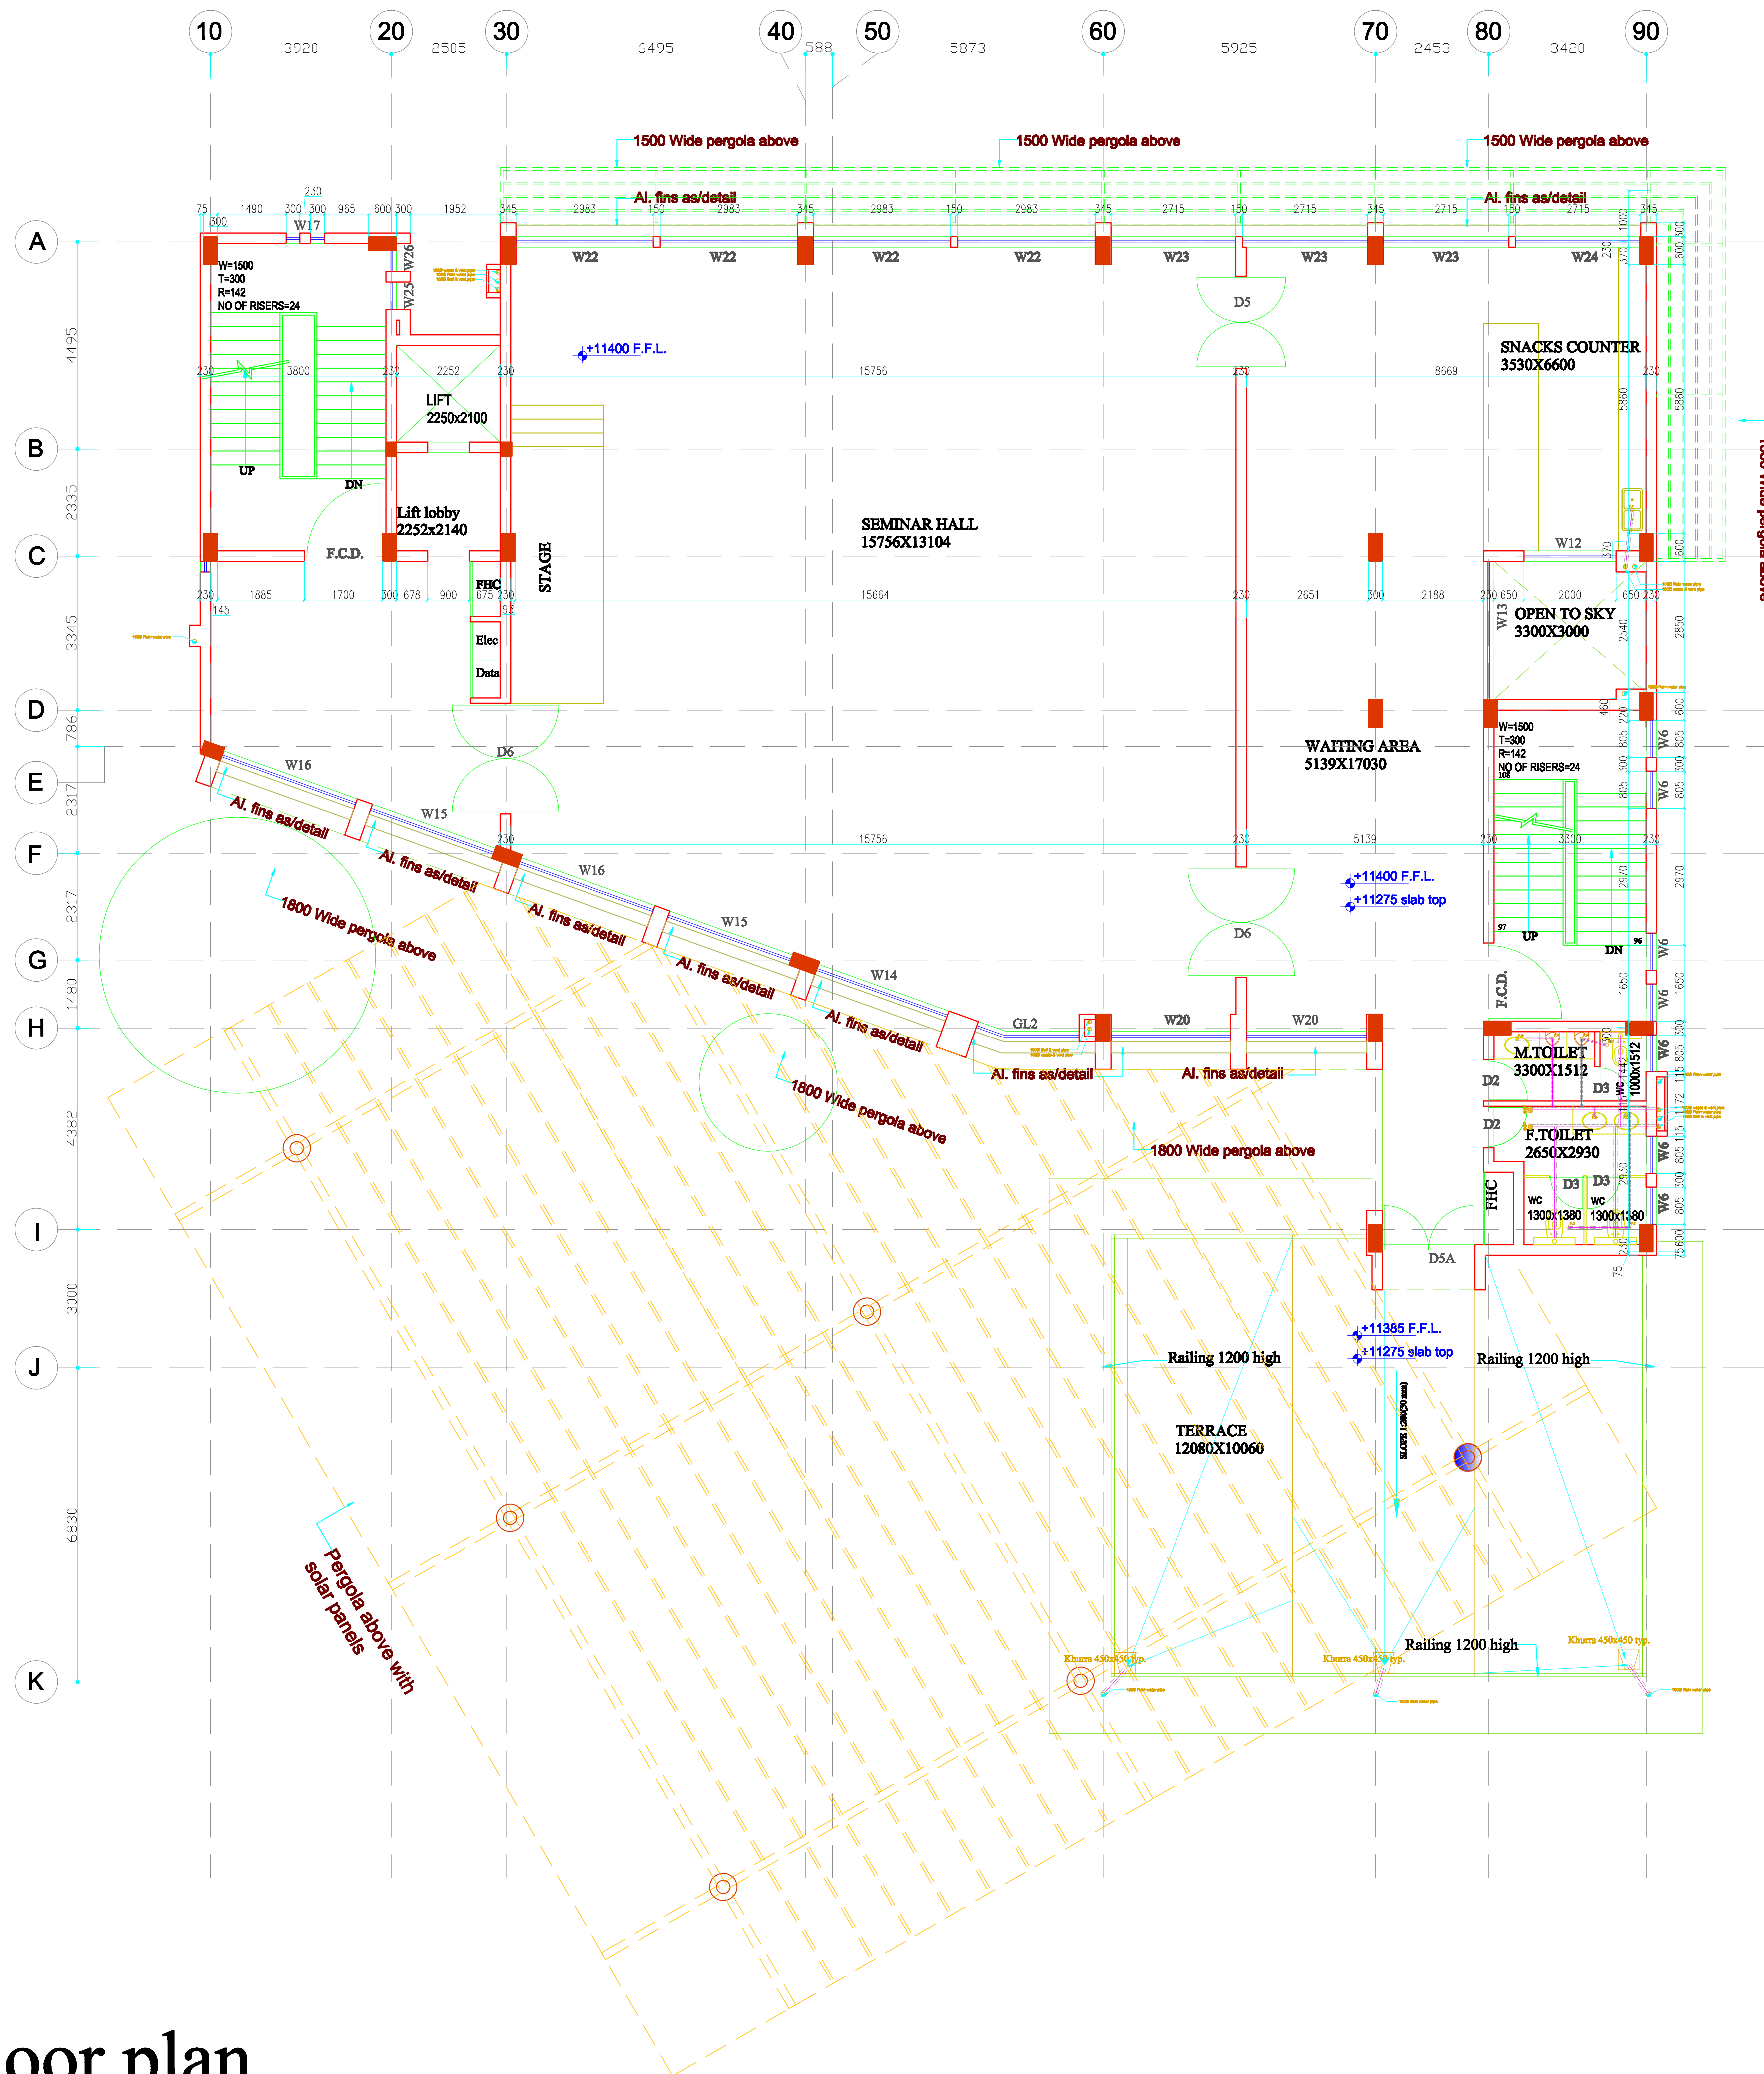

NOTES

- THIS DRAWING IS INTELLECTUAL COPYRIGHT OF "MS PRABHAT KUMAR & ASSOCIATES"
- WRITTEN DIMENSION TO BE FOLLOWED, DRAWING NOT TO BE SCALED.
- CONTRACTOR MUST VERIFY ALL DIMENSION ON SITE BEFORE COMMENCING ANY WORK.

NOTE :- 1. Cover 40 mm in exposed R.C.C. Slabs, beams and vertical walls in place of normal 25 mm

- Coordinated with
- Structure
 - Sanitary / Water Supply
 - HVAC
 - Electrical
 - Interior
 - Landscape

Architects
Prabhat Kumar & Associates
architects, planners and project management consultants
RMT-318, B-2, Mahaveera Tower, LSC,
Next to Geetanjali Hospital, Geetanjali,
Near Aurobindo College, ND-17.
Ph.: 011-41882293, 9889228494, 988555511
E-mail: prabhat_arch@yahoo.com

Project
PROPOSED RESEARCH CENTER
HINDU COLLEGE, DELHI
UNIVERSITY, DELHI

Client
HINDU COLLEGE, DELHI
UNIVERSITY, DELHI

Title
THIRD FLOOR WORKING PLAN
THIRD FLOOR SANITARY PLAN

Date
08.03.2016
Scale

Checked by
PRABHAT

Drawn by
KARAN SHARMA

Project no.
1008

Drawing no.
PL - 08

