
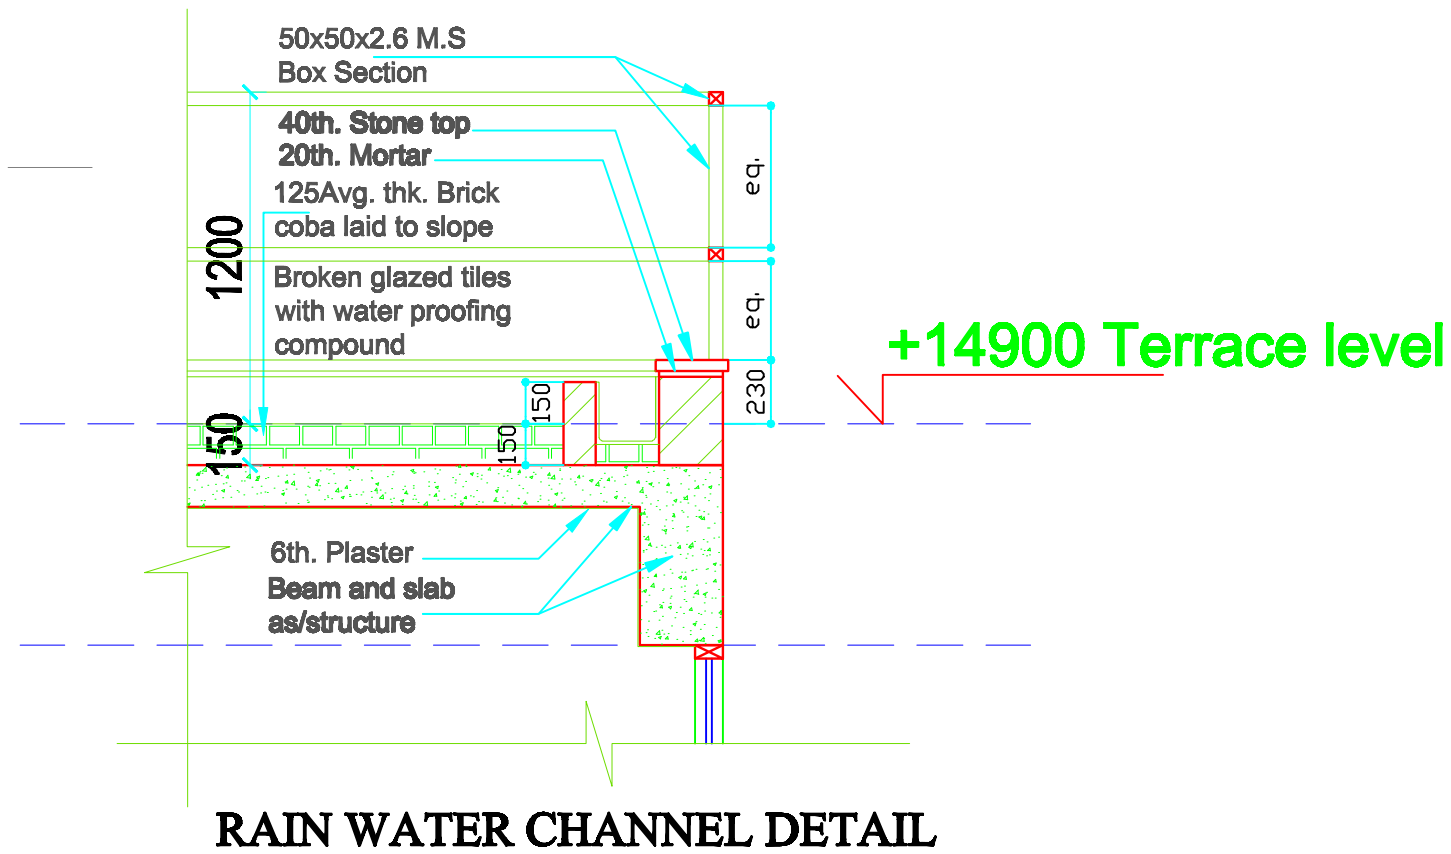


Terrace plan

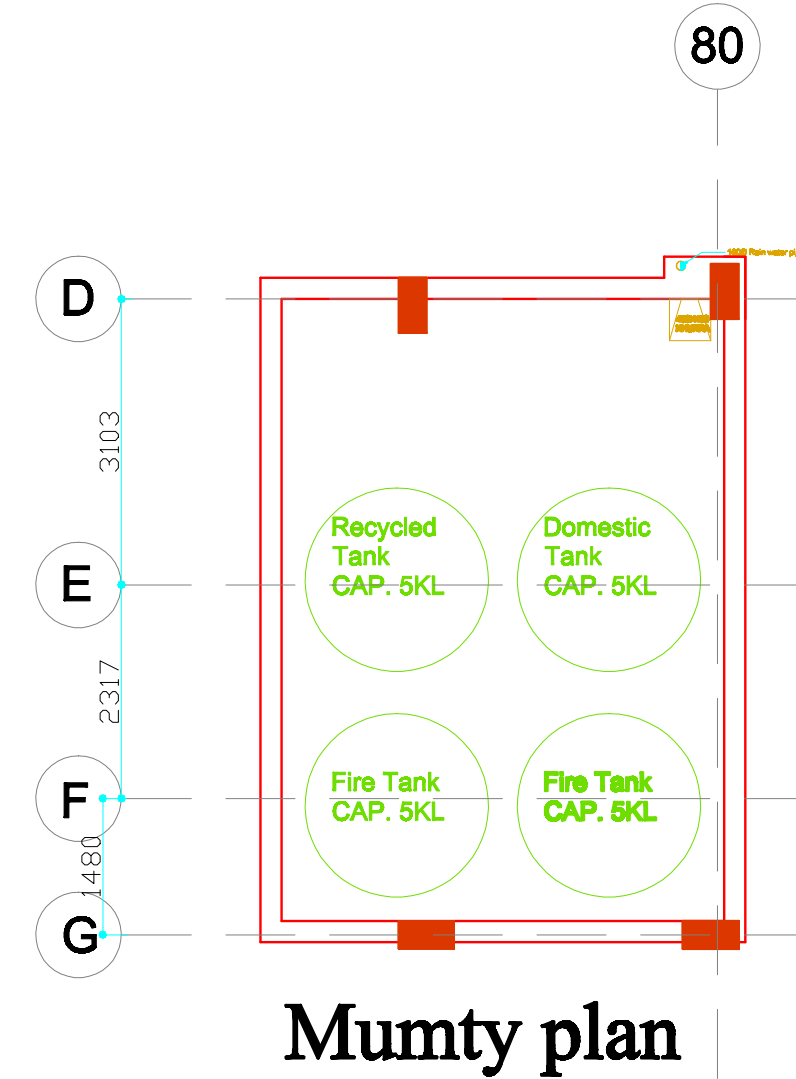

NOTES

- THIS DRAWING IS INTELLECTUAL COPYRIGHT OF "MS PRABHAT KUMAR & ASSOCIATES"
- WRITTEN DIMENSION TO BE FOLLOWED, DRAWING NOT TO BE SCALED.
- CONTRACTOR MUST VERIFY ALL DIMENSION ON SITE BEFORE COMMENCING ANY WORK.

NOTE :- 1. Cover 40 mm in exposed R.C.C. Slabs, beams and vertical walls in place of normal 25 mm

Coordinated with

- Structure
- Sanitary / Water Supply
- HVAC
- Electrical
- Interior
- Landscape

Architects

Prabhat Kumar & Associates
architects, planners and project management consultants
RMT-316, B-2, Mahaveera Tower, LSC,
Next to Geetanjali Hospital, Geetanjali,
Near Aurobindo College, ND-17.
Ph: 011-41882293, 9889228494, 988555511
E-mail: prabhat_arch@yahoo.com

Project

PROPOSED RESEARCH CENTER
HINDU COLLEGE, DELHI
UNIVERSITY, DELHI

Client

HINDU COLLEGE, DELHI
UNIVERSITY, DELHI

Title

TERRACE WORKING PLAN
TERRACE SANITARY PLAN

Date

08.03.2016

Scale

Scale

Checked by

PRABHAT

Drawn by

KARAN SHARMA

Project no.

1008

Drawing no.

PL - 08