


Second floor plan

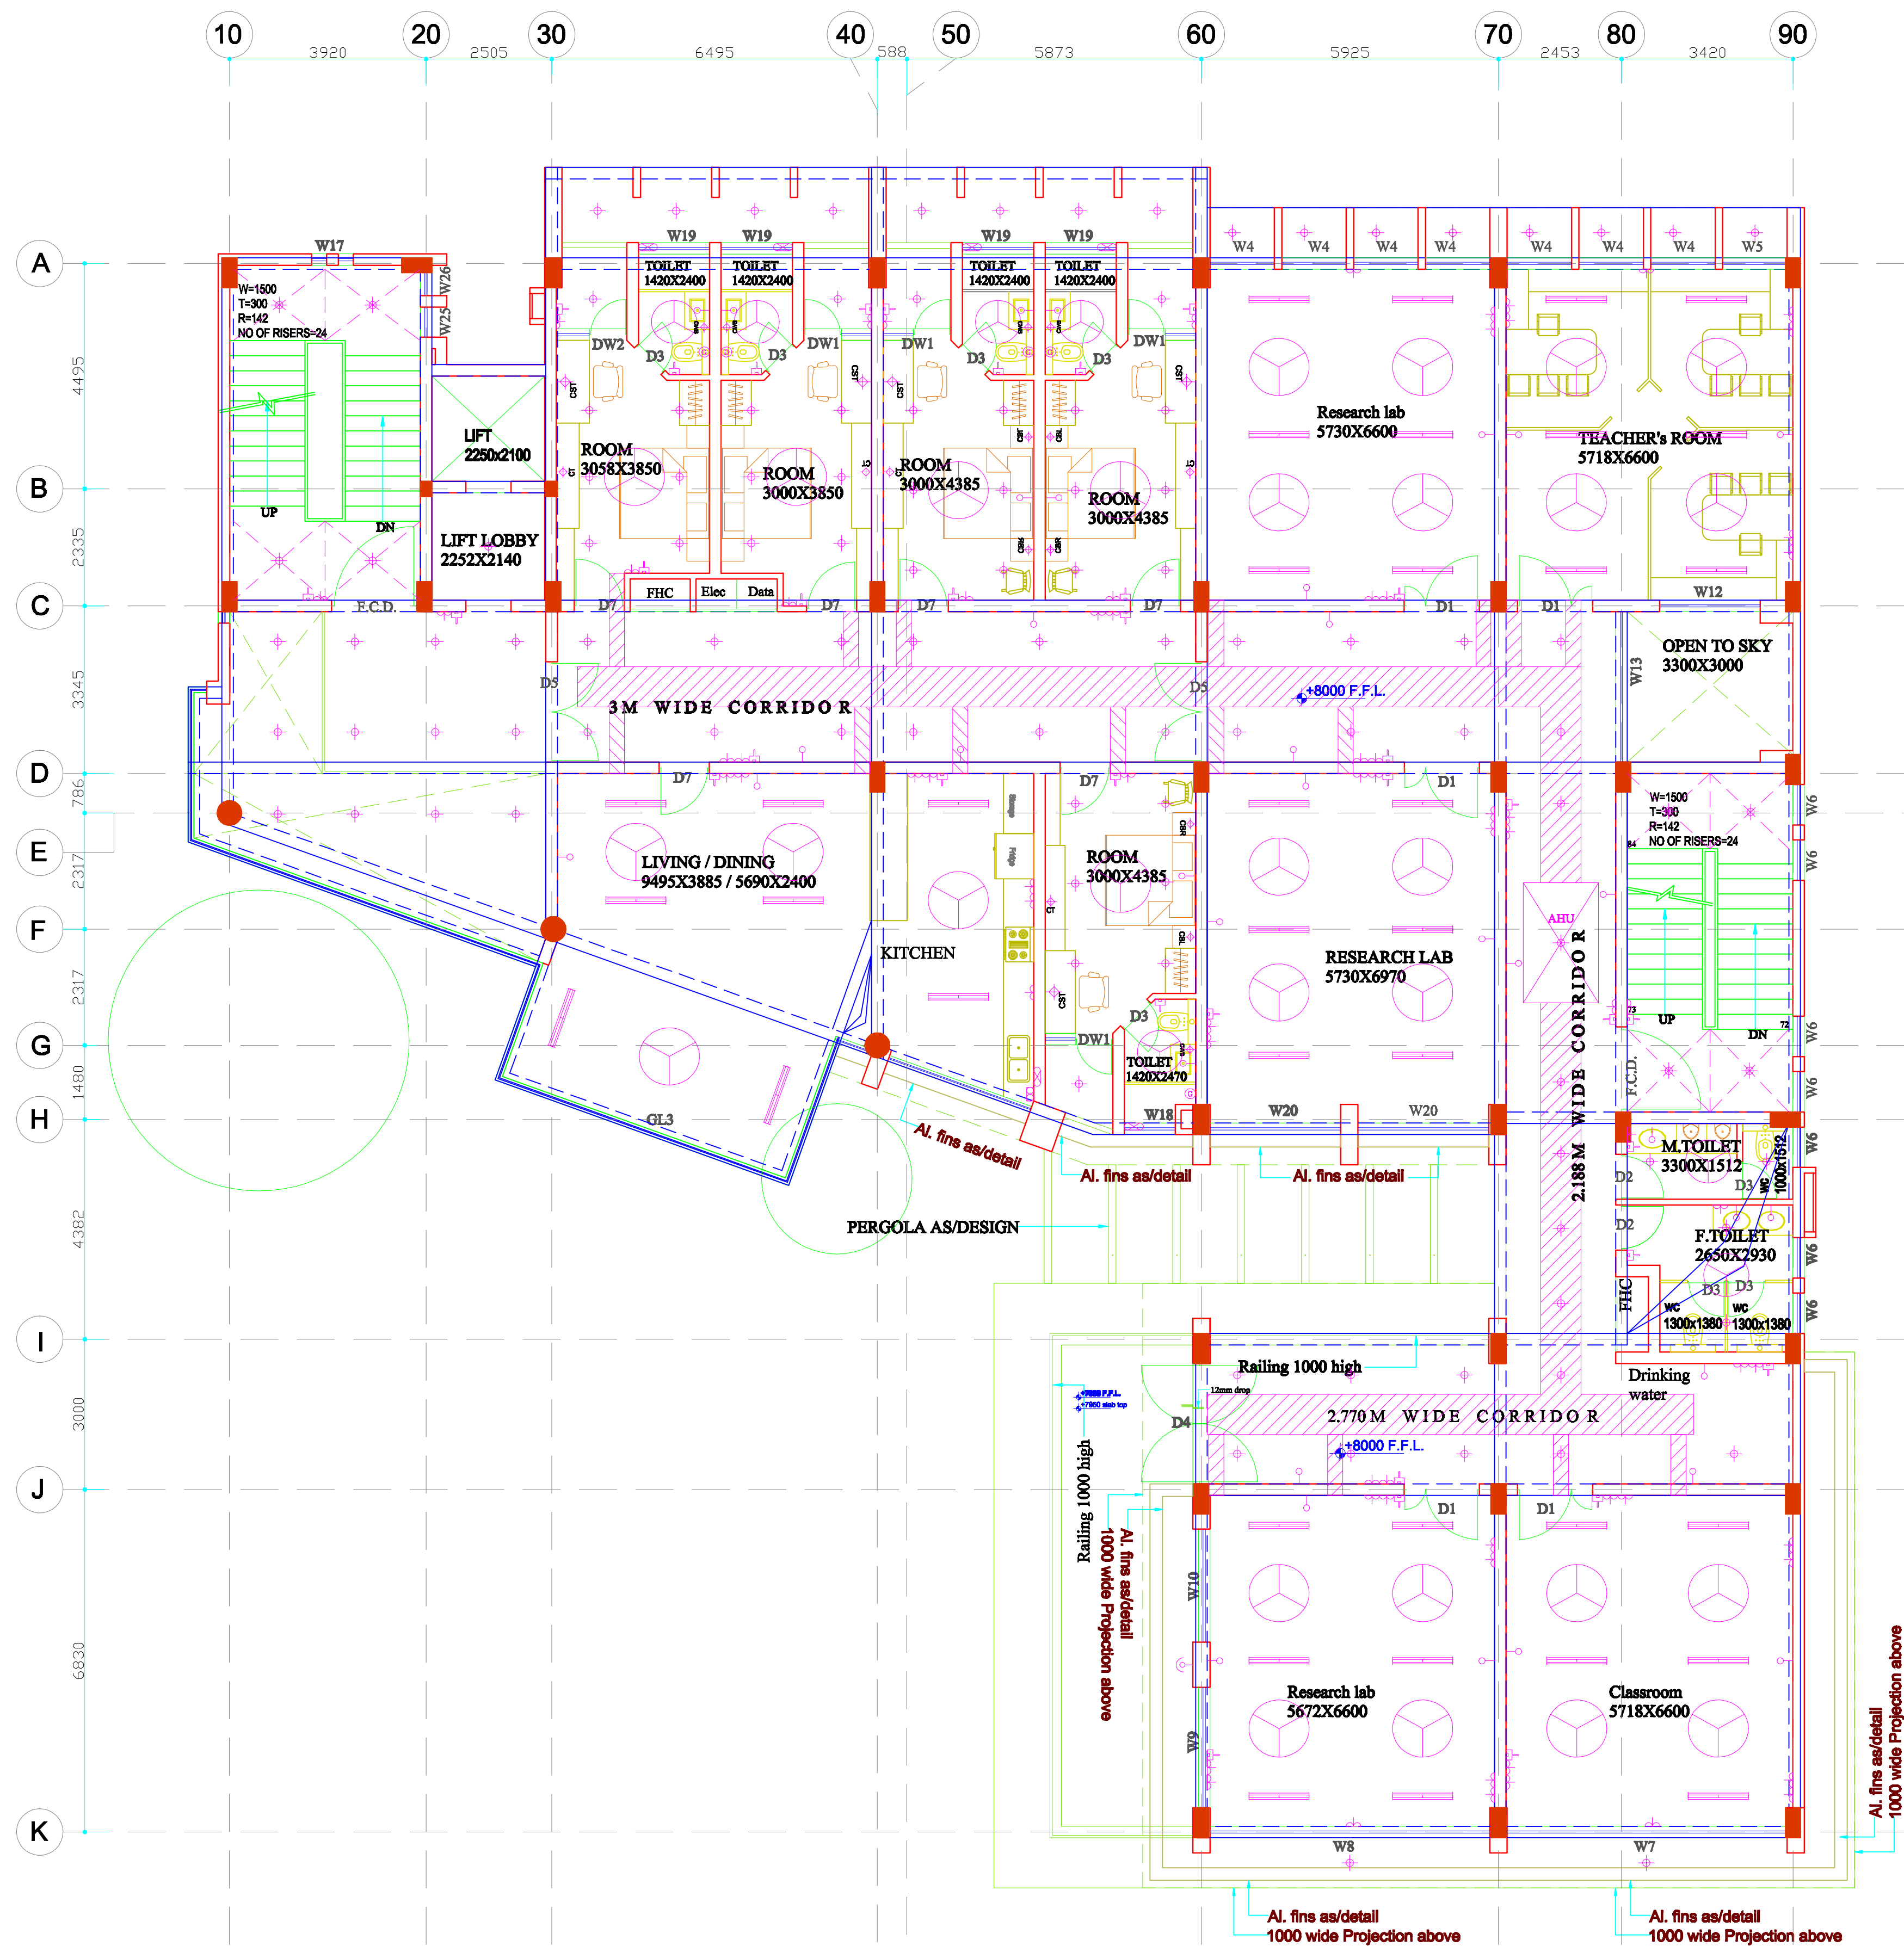

NOTES

- THIS DRAWING IS INTELLECTUAL COPYRIGHT OF "MS PRABHAT KUMAR & ASSOCIATES"
- WRITTEN DIMENSION TO BE FOLLOWED, DRAWING NOT TO BE SCALED.
- CONTRACTOR MUST VERIFY ALL DIMENSION ON SITE BEFORE COMMENCING ANY WORK.

NOTE:- 1. Cover 40 mm in exposed R.C.C. Slabs, beams and vertical walls in place of normal 25 mm

Schedule of Electrical Fitting		
Index	Symbol	Height
SWING SWITCH		+400
CALL BELL SWITCH		+400
T.V. ON WALL BRACKET		+2100
SPLIT A.C.		500 BELOW CEILING
A.C. Power point & stabilizer		as per window
Tube light		as per window
Spot Light		+1400 for ceiling lights
Breaker Light		as per window
Ceiling/hood Light		+2100
Telephone		+1400/1500
T.V. Antenna		+450/table top
Plug Point 5Amp.		+400/+450
Power Point 15Amp.		+400/+450
Switch Board		+400
Buzzer		+2100
Exhaust Fan		as per window
Day-sensor with power switch at BS		+2100
Gate Light		As per design
Hanging Light		as per design
Monitor		+900
CC T.V. Camera		+2100
Fan		as per design
Intruder sensor		300 below ceiling
Chandelier/ Multi-hanging light		as per design
Wall Fan		+2100
Speaker		as per design
Letter box light		+1200
Recessed Light		+450
Track Light		as per design
magnetic contact		in door
security bell		+2100
water light		as per design
Search light		as per design
Electrical emergency with flood light		as per design
Water purifier		as per design
Electrical panel		as per design
Distribution board		as per design
Curtain actuator (BAMP FLAT)		+2400
BEVERAGE PUMP		as per design
PROJECTOR		as per design
Vertical BOLLARD Light		as per design
Plant Focus Light		as per design
Foot Light		+300 / as per design
Floor Light		in floor as per design
Built Head Light		+2100
Upward focus light		as per design

- NOTE:-
- All level are Taken From Finish Floor Level.
 - Ceiling fan can be placed where marked. (For Toilets Only)
 - Bed side electrical points may be at +450.
 - Power points shall be at +1050 on the kitchen/ toilet counters
 - Co-ordinate points with furniture heights
 - All Concealed Ceiling Light are in 5" Recessed box

Combinations	Symbol	Height
Bed side Light Board		450 mm A.P.F.
Bed side Light Board		450 mm A.P.F.
TV cabinet		450 mm A.P.F.
Wash Basin Counter		850 mm A.P.F. for basin counter
Study table		850 mm A.P.F. for study table
For Drives		850 mm A.P.F. for drives

AC Copper pipe
AC drainage pipe

- Coordinated with
- Structure
 - Sanitary / Water Supply
 - HVAC
 - Electrical
 - Interior
 - Landscape

Prabhat Kumar & Associates
architects, planners and project management consultants
RMT-316, B-2, Mahaveera Tower, LSC,
Next to Geetanjali Hospital, Geetanjali,
Near Aurobindo College, ND-17.
Ph: 011-41882293, 9888922494, 9888555511
E-mail: prabhat_arch@yahoo.com

Project
PROPOSED RESEARCH CENTER
HINDU COLLEGE, DELHI
UNIVERSITY, DELHI

Client
HINDU COLLEGE, DELHI
UNIVERSITY, DELHI

Title
SECOND FLOOR ELECTRICAL PLAN

Scale
08.03.2016

Drawn by
PRABHAT

Project no.
1008

Drawing no.
EL-04

