


Third floor plan

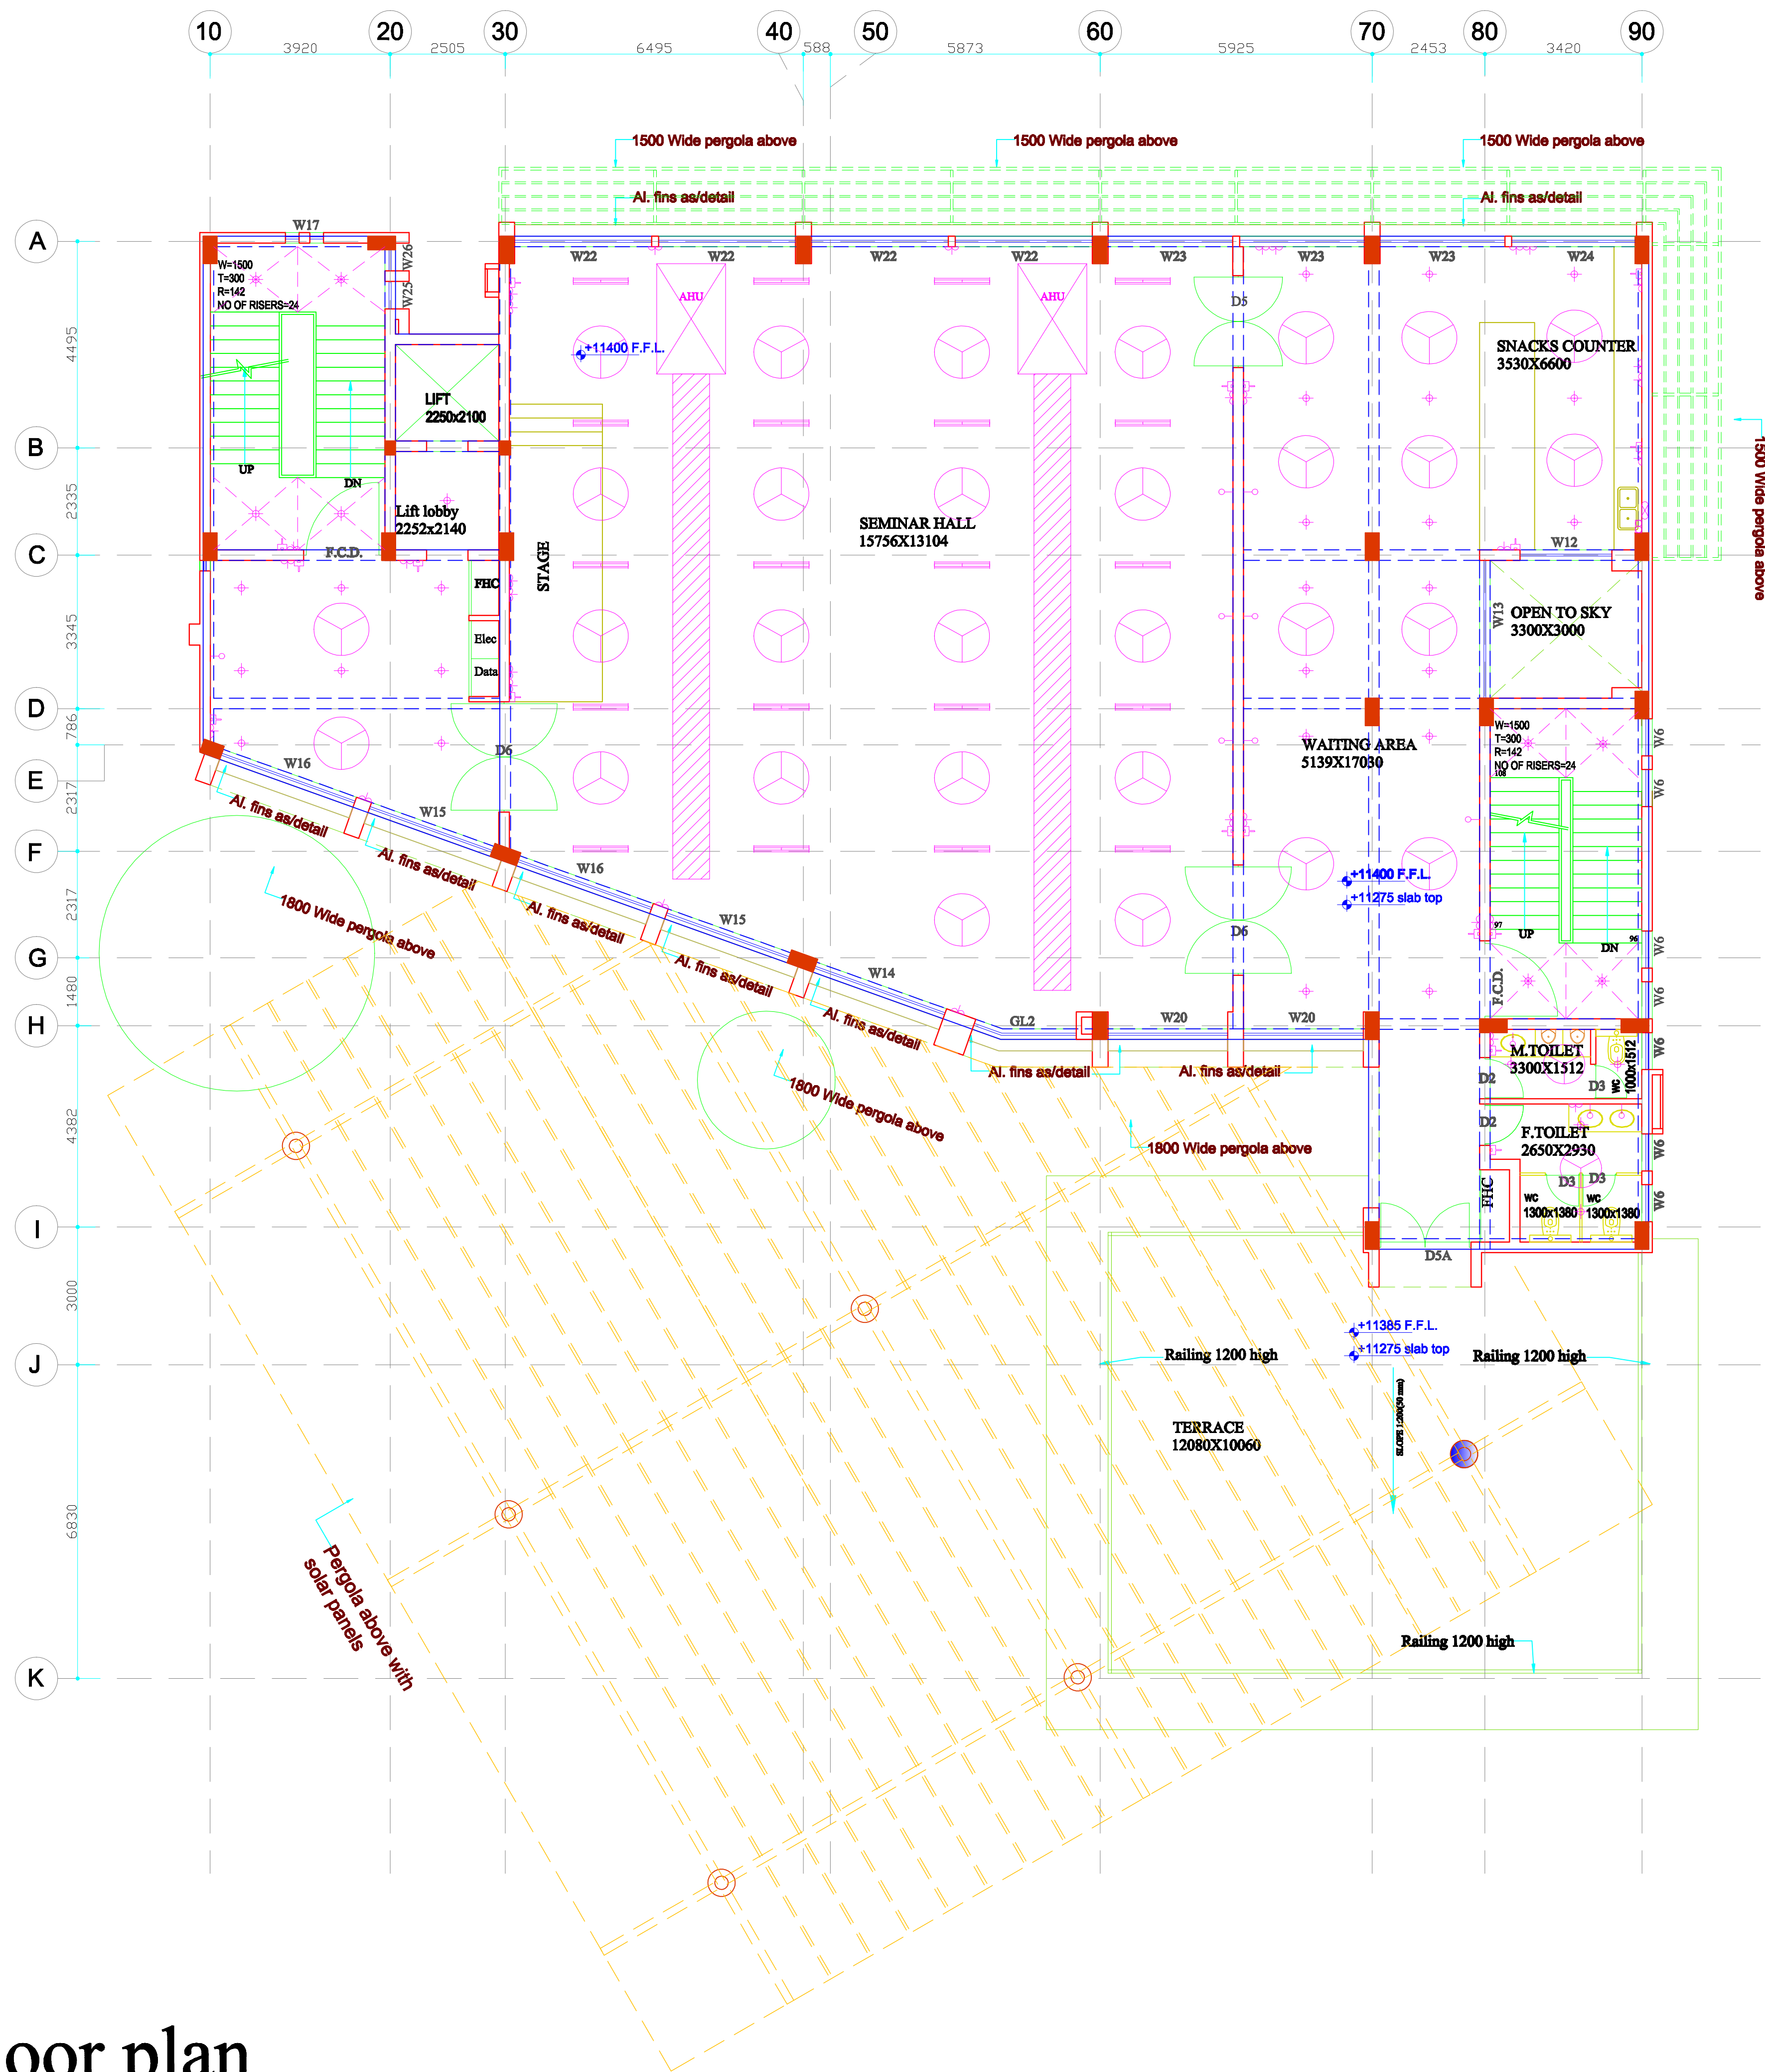

NOTES

- THIS DRAWING IS INTELLECTUAL COPYRIGHT OF "MS PRABHAT KUMAR & ASSOCIATES"
- WRITTEN DIMENSION TO BE FOLLOWED, DRAWING NOT TO BE SCALED.
- CONTRACTOR MUST VERIFY ALL DIMENSION ON SITE BEFORE COMMENCING ANY WORK.

NOTE:- 1. Cover 40 mm in exposed R.C.C. Slabs, beams and vertical walls in place of normal 25 mm

Schedule of Electrical Fitting

Index	Symbol	Height
INDEX SWITCH		+400
CALL BELL SWITCH		+400
T.V. ON WALL BRACKET		+2100
SPLIT A.C.		500 BELOW CEILING
A.C. Power point & stabilizer		as per window
Tube light		Ceiling
Spot Light		Ceiling
Breaker Light		+2100
Ceiling/hood Light		Ceiling/hood
Telephone		+450/500 table top
T.V. Antenna		+450/500 table top
Plug Point 5Amp.		+400/+450
Power Point 15Amp.		+400/+450
Switch Board		+400
Buzzer		+2100
Exhaust Fan		as per window
Daylight socket with power switch at 50		+2100
Ceiling Light		As per design
Hanging Light		Ceiling
Monitor		+900
CC T.V. Camera		+2100
Fan		Ceiling
Intruder sensor		300 below ceiling
Chandelier/ Multi-hanging light		Ceiling
Wall Fan		+2100
Speaker		wall as/detail
Letter box light		+1200
Recessed Light		+450
Track Light		Ceiling
magnetic contact		In door
security bell		+2100
water light		as/design
Search light		as/design
Electrical emergency with flood light		as/manufact.
Water purifier		as/manufact.
Electrical panel		as/manufact.
Distribution board		as/manufact.
Curtain actuator (BAMP F.L.O.D)		+2400
BEVERAGE PUMP		
PROJECTOR		Ceiling
Vertical BOLLARD Light		as/manufact.
Plant Focus Light		as/design
Floor Light		+300 / as/design
Floor Light		In floor as/design
Built Head Light		+2100
Upward focus light		as/design

NOTE:-
1. All level are Taken From Finish Floor Level.
2. Ceiling fan can be placed where marked. (For Toilets Only)
3. Bed side electrical points may be at +450.
4. Power points shall be at +1050 in the kitchen/ toilet counters
5. Co-ordinate points with furniture heights
6. All Concealed Ceiling Light are in 5" Recessed box

Combinations

Bed side	TV cabinet	Wash Basin Counter	Study table	For Dress
Bed side	TV cabinet	Wash Basin Counter	Study table	For Dress

AC Copper pipe
AC drainage pipe

Coordinated with

- Structure
- Sanitary / Water Supply
- HVAC
- Electrical
- Interior
- Landscape

Architects

Prabhat Kumar & Associates
architects, planners and project management consultants
RMT-316, B-2, Mahaveera Tower, LSC,
Next to Geetanjali Hospital, Geetanjali,
Near Aurobindo College, ND-17.
Ph: 011-41882293, 9888228494, 9888585511
E-mail: prabhat_arch@yahoo.com

Project

PROPOSED RESEARCH CENTER
HINDU COLLEGE, DELHI
UNIVERSITY, DELHI

Client

HINDU COLLEGE, DELHI
UNIVERSITY, DELHI

Title

THIRD FLOOR ELECTRICAL PLAN

Scale

1:50

Checked by

PRABHAT

Drawn by

KARAN SHARMA

Project no.

1808

Drawing no.

EL - 05